


- KEY**
- BH - Borehole
 - OB - Observation Well
 - PW - Pumping Well
 - TP - Trial Pit

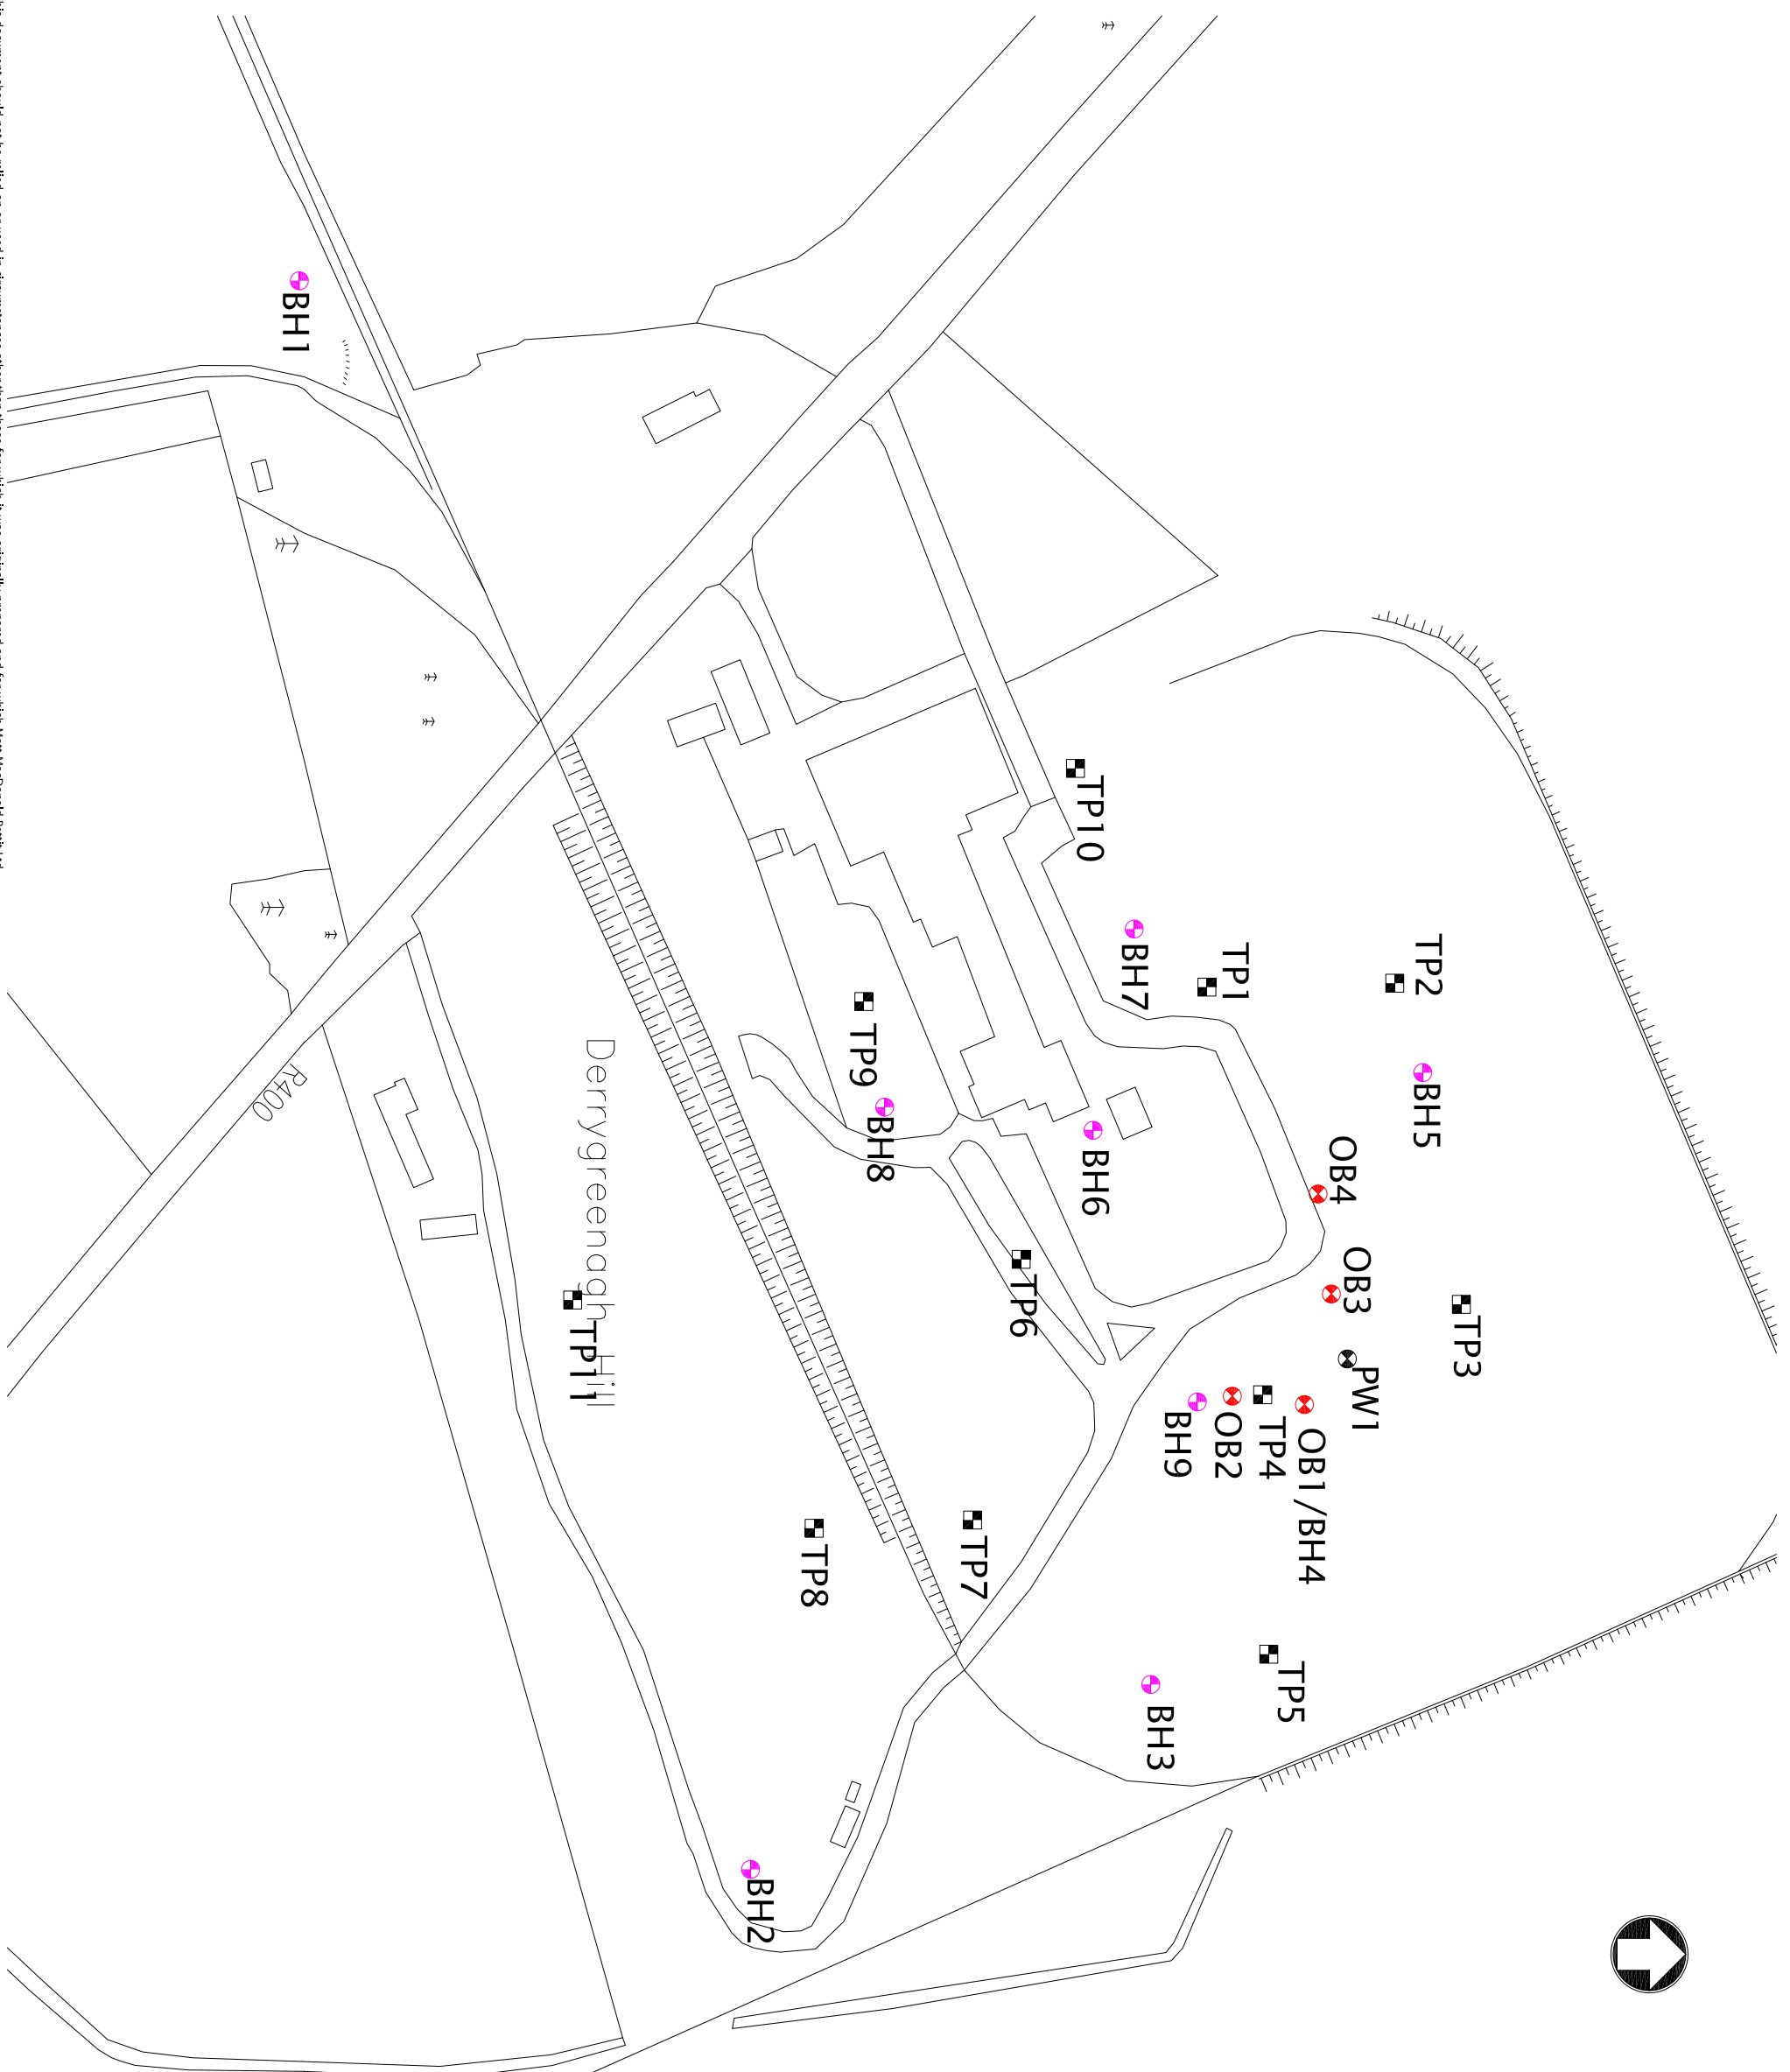

This document should not be relied on or used in circumstances other than those for which it was originally prepared and for which Mott MacDonald Perit Ltd was commissioned. Mott MacDonald Perit Ltd accepts no responsibility for this document to any other party other than the person by whom it was commissioned.

Ordnance Survey/ Ireland Licence No. EN0004509
©Ordnance Survey/ Ireland/Government of Ireland

Mott MacDonald		<small>Mott MacDonald Perit Ltd. South Block, Rodfield Dundrum, Dublin 16, Ireland Tel: +353 (0) 291 6700 Fax: +353 (0) 291 6747 Web: www.mottmacperit.ie Email: engineers@mottmacperit.ie</small>	
Client		BORD NA MÓNA ENERGY LIMITED	
DERRYGREENAGH, ROCHFORTBRIDGE, MULLINGAR, CO. WESTMEATH			
Title			
Bord na Mona Derrygreenagh Power Plant Ground Investigations			
Designed	SK	Eng.Chk.	DM
Drawn	SK	Coordination	PH
DWG.Chk.	DM	Approved	PK
Scale	NTS	Project	243190
CAD file	243190_BRD230MVA/PLANT/GRDINV/CH7	Status	PRE
Drawing No	Figure 7.1	Rev	P2