



PROPOSED PIPELINE

 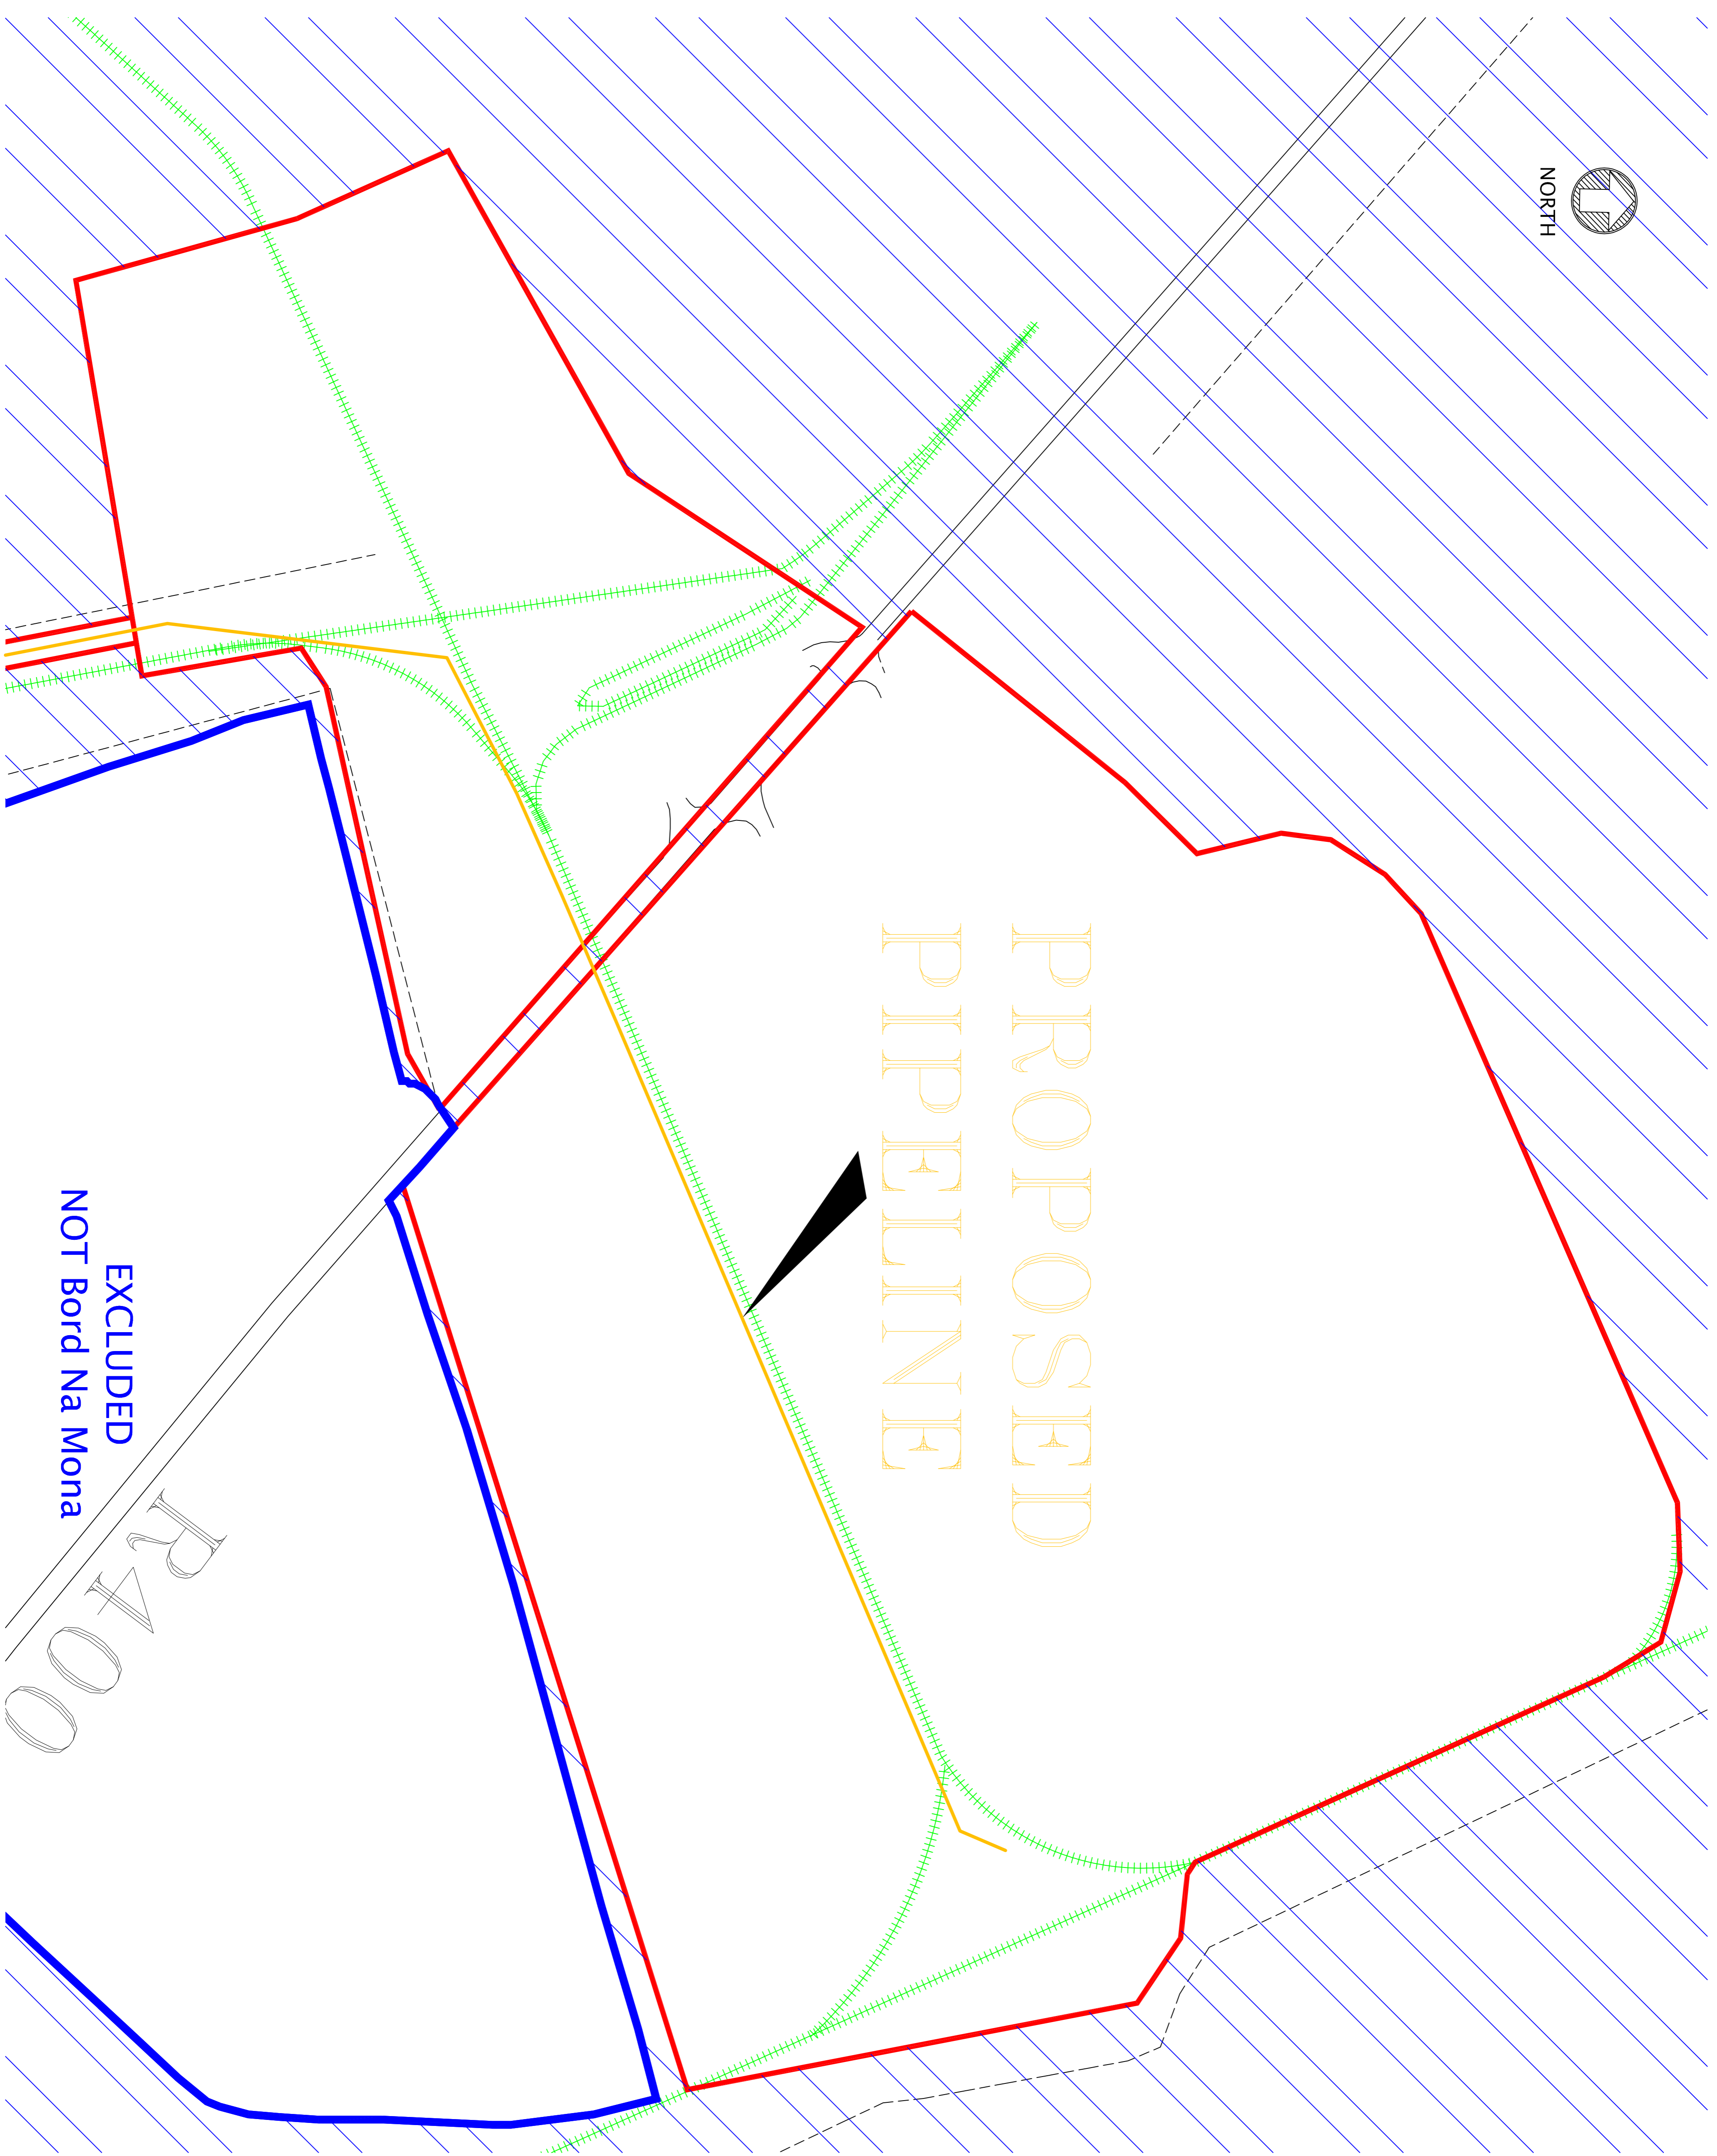


Notes

- Pipeline —
- Boundary —
- River —
- BNM Adjacent Land —
- Rail Line (Not to be removed) +++++
- Headland ---
- Access Road ---

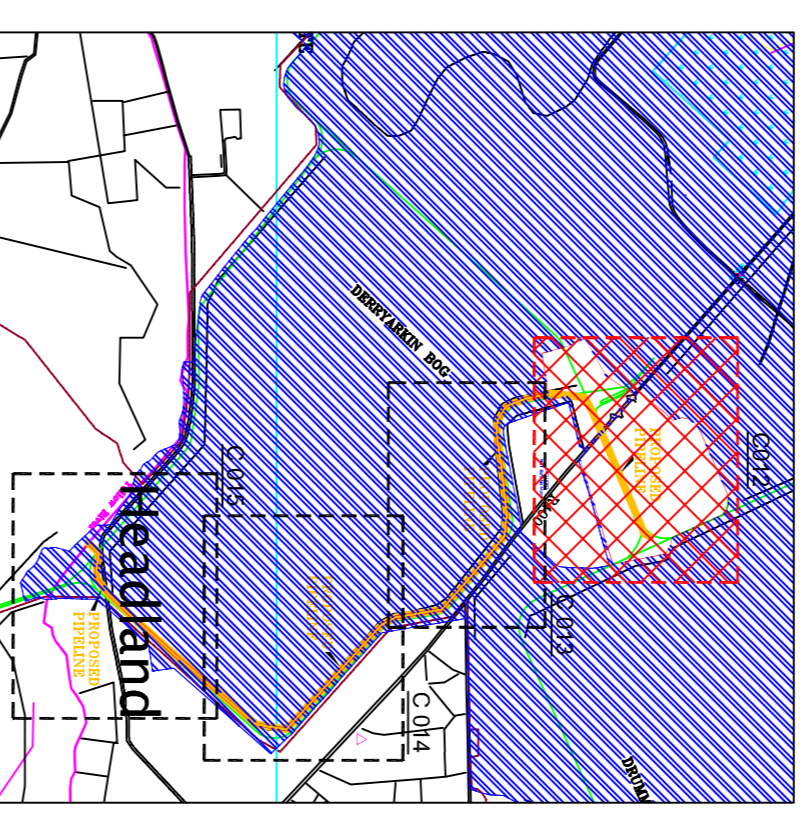

Scale:



Rev	Date	Drawn	Description	CHK'd	App'd
R1	27/02/09	REN	Issue For Planning Application	DMR	DMR
R0	15/12/08	REN	Issue For Comments	DMR	DMR

M Mott MacDonald

Mott MacDonald
 South Block, Rockfield,
 Dundrum, Dublin 16,
 Ireland
 Tel: +353 (0) 291 6700
 Fax: +353 (0) 291 6744
 Web: www.mottmac.com
 Email: engineers@mottmacpetit.ie

BORD NA MÓNA
 BORD NA MONA ENERGY LIMITED
 DERRYGREENAGH, ROCHFORTHBRIDGE,
 MULLINGAR, CO. WESTMEATH

The
 Bord na Mona Energy
 Proposed Power Plant at Derrygreenagh
 Proposed Discharge Pipe Route
 Sheet 1 of 4

Designated	Eng. Chk.	Donal McEandall
Designed	R Evers-Norton	
Drawn	R Evers-Norton	
Dwg. Chk.	Donal McEandall	
Project	243190	Status
Scale	1:1250	PRE
CAD file	243190 C 012.dwg	
Drawing No	243190 C 012	Rev R1

This document should not be relied on or used in circumstances other than those for which it was originally prepared and for which Mott MacDonald Pettit Ltd was commissioned. Mott MacDonald Pettit Ltd accepts no responsibility for this document to any other party other than the person by whom it was commissioned.

FOR CONTINUATION OF DRAWING
 REFER TO SHEET 2 OF 4