



 






Notes

- Pipeline 
- Boundary 
- River 
- BNM Adjacent Land 
- Rail Line (Not to be removed) 
- Headland 
- Access Road 




Rev	Date	Drawn	Description	CHK'd	App'd
R1	27/02/09	REN	For Information Purposes Only	DMR	DMR
R0	15/12/08	REN	Issue For Comments	DMR	DMR

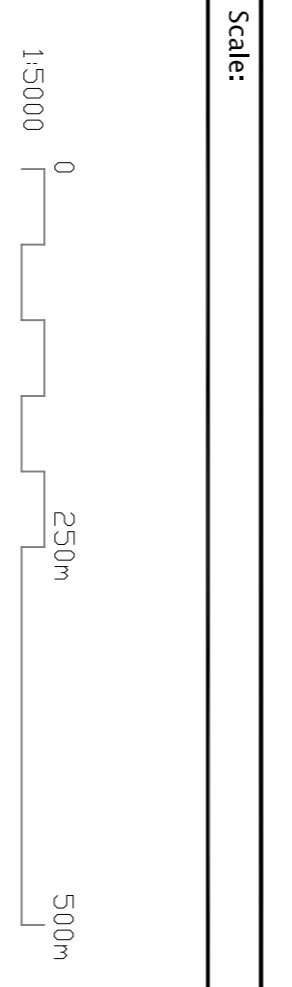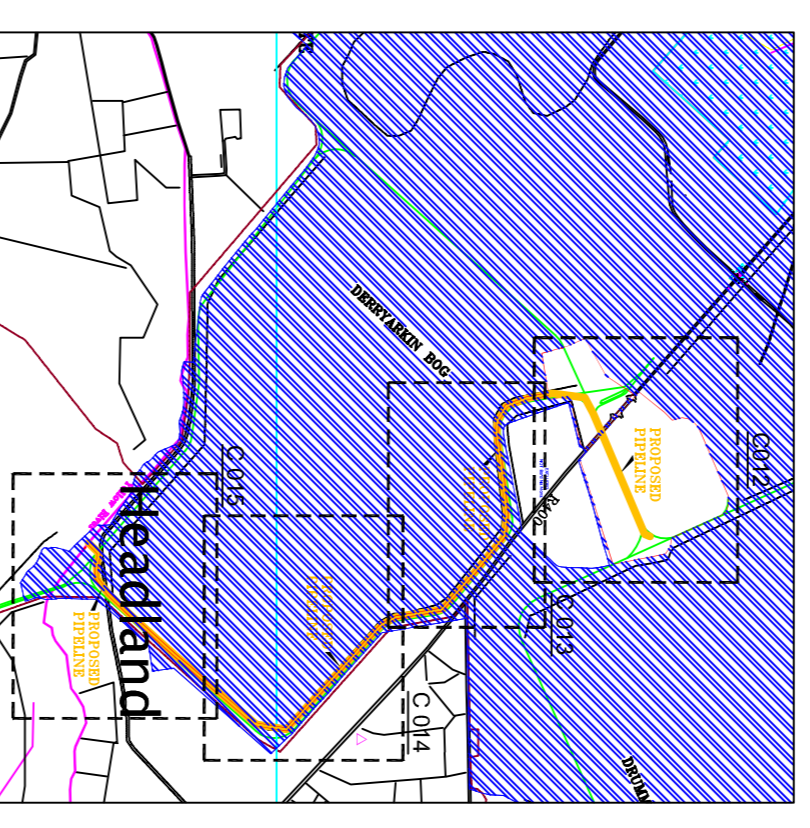M M Mott MacDonald
 Mott MacDonald Print Ltd.
 South Block, Rockfield,
 Drumlam, Dublin 16,
 Ireland
 Tel: +353 (0) 291 6700
 Fax: +353 (0) 291 6701
 Web: www.mottmac.com
 Email: engineers@mottmacpetit.ie

BORD NA MÓNA
BOND NA MONA ENERGY LIMITED
 DERRYGREENAGH, ROCHFORTHBRIDGE,
 MULLINGAR, CO. WESTMETH

The Bord na Mona Energy Proposed Power Plant at Derrygreenagh Proposed Discharge Pipe Route Key Plan

Designed	R. Evers-Norton	Eng. Chk.	Donal McEandall
Drawn	R. Evers-Norton	Coordination	
Dwg. Chk.	Donal McEandall	Approved	D. McEandall
Scale	1:5000	Project	243190
		CAD file	243190 C.012.dwg
Drawing No	243190 C.012 A	Status	INF
		Rev	R1

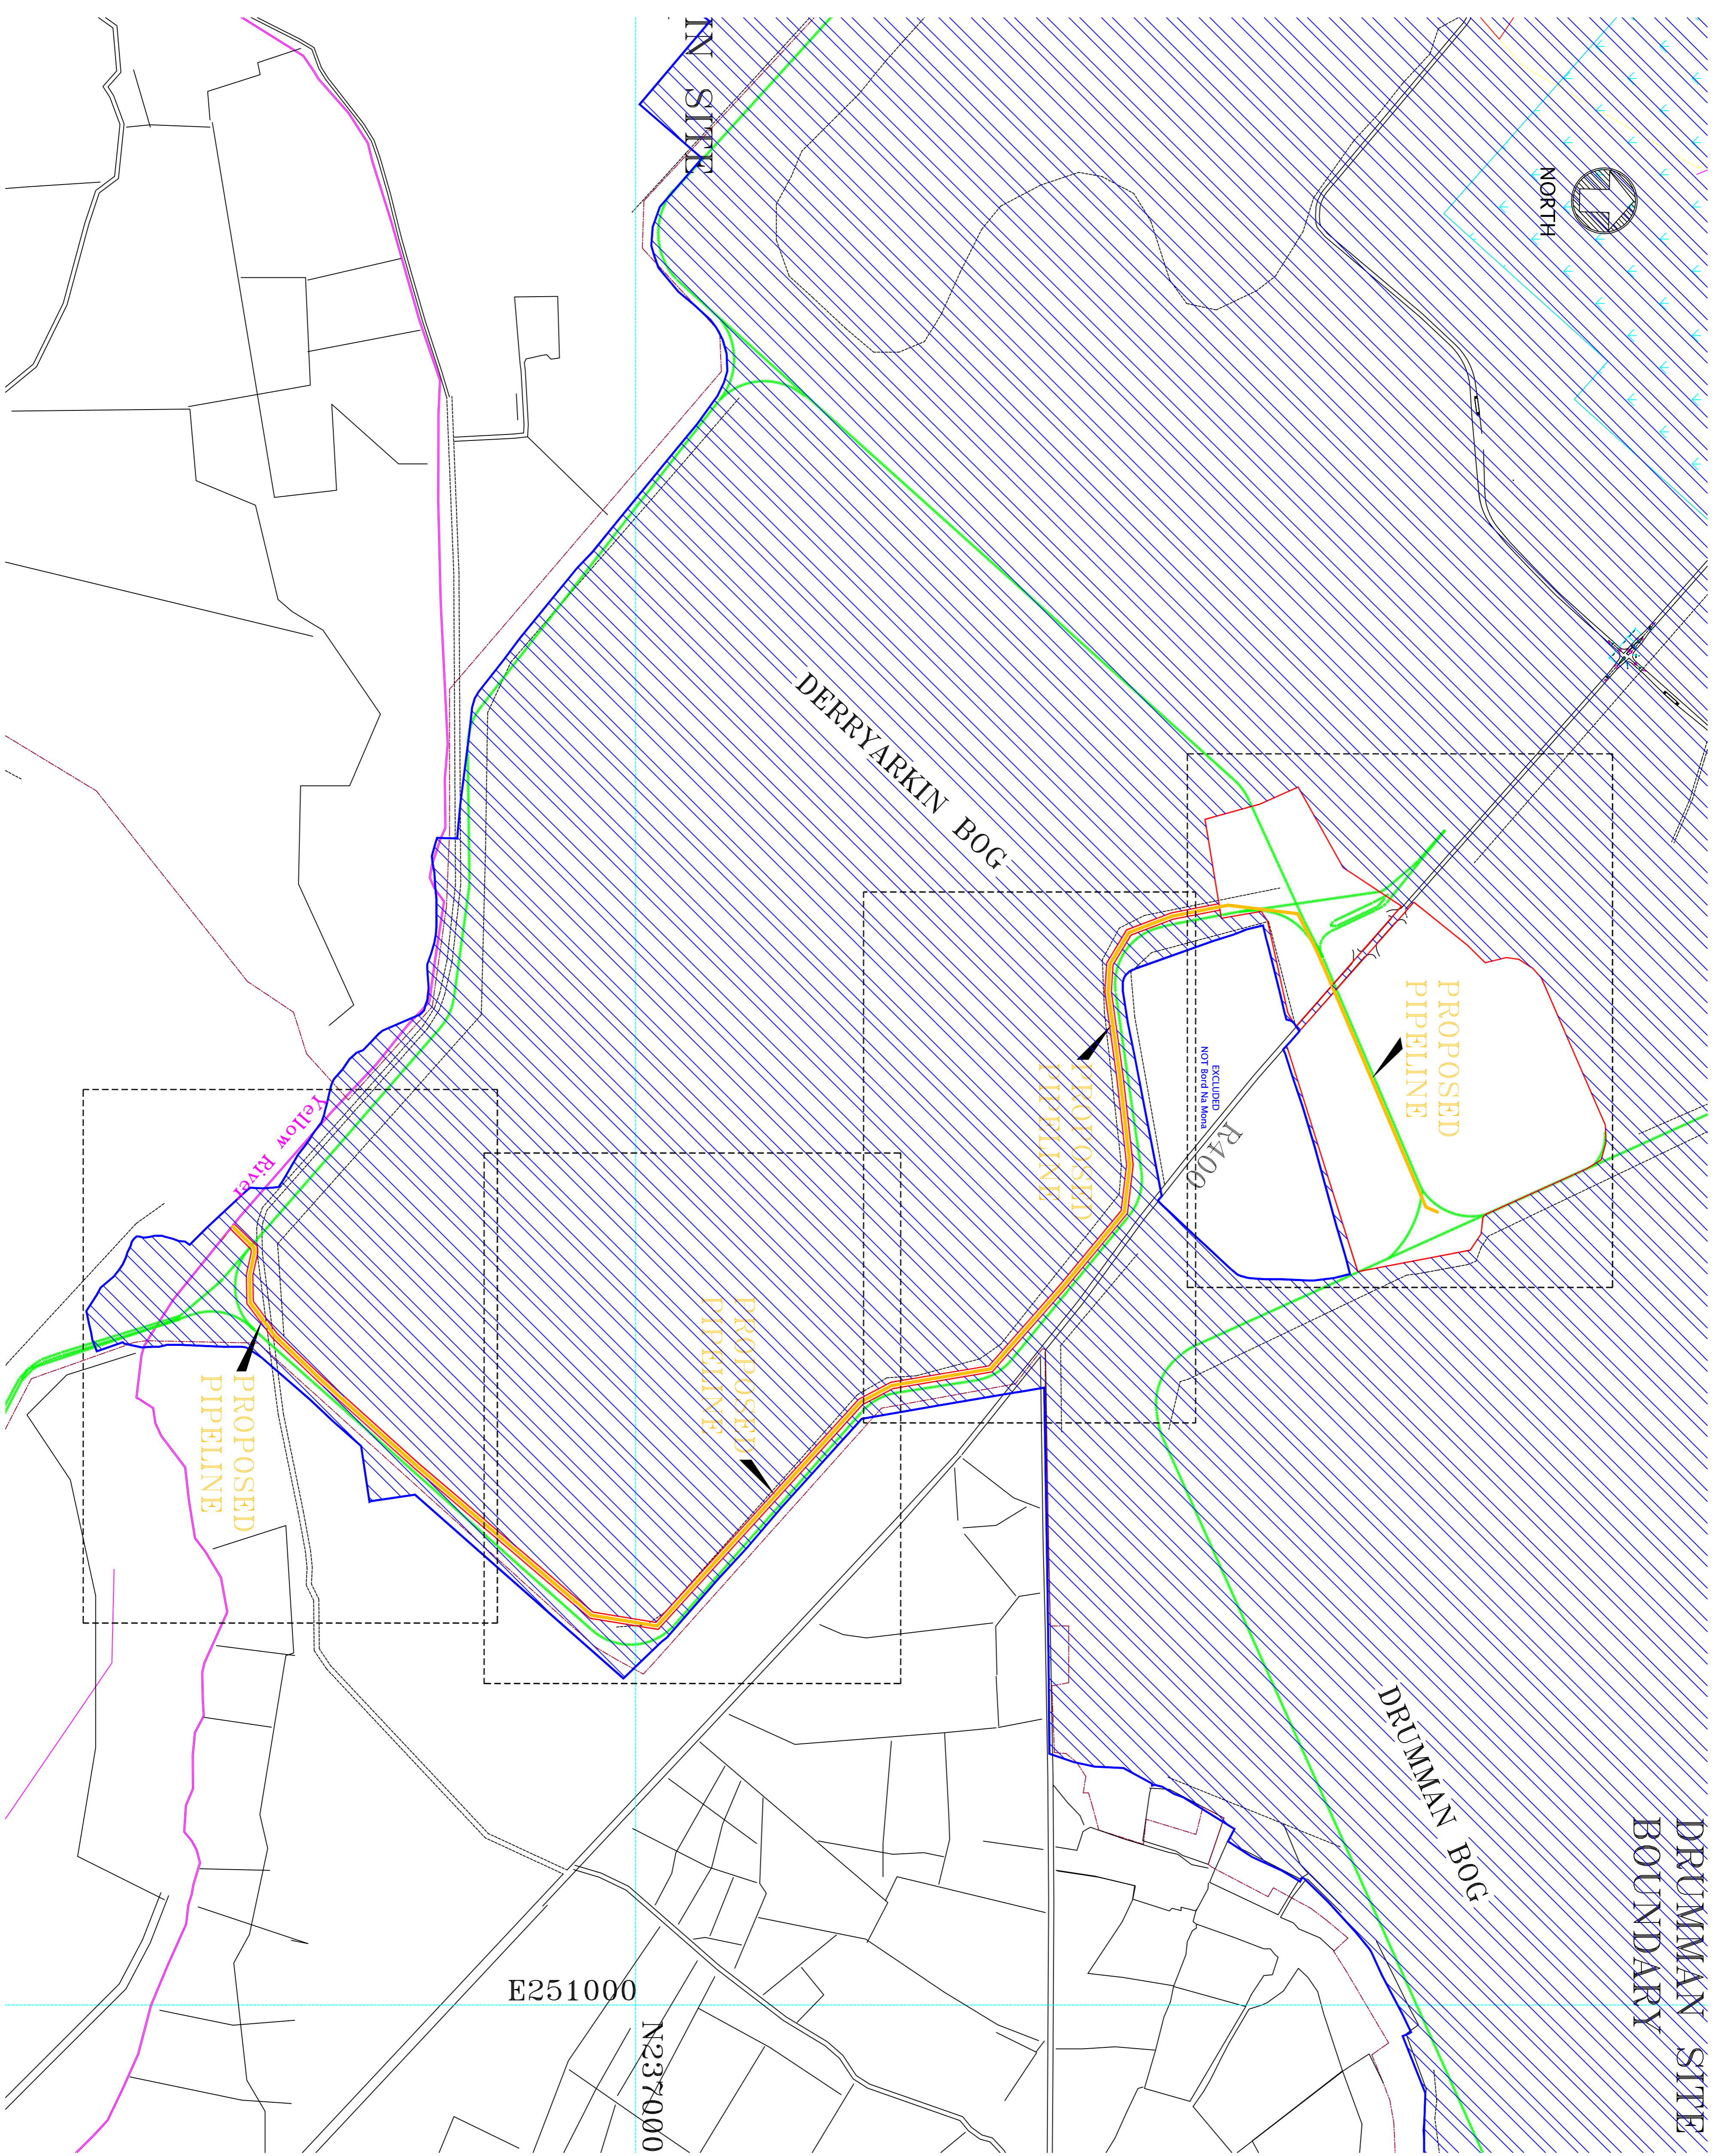

This document should not be relied on or used in circumstances other than those for which it was originally prepared and for which Mott MacDonald Pettit Ltd was commissioned. Mott MacDonald Pettit Ltd accepts no responsibility for this document to any other party other than the person by whom it was commissioned.