

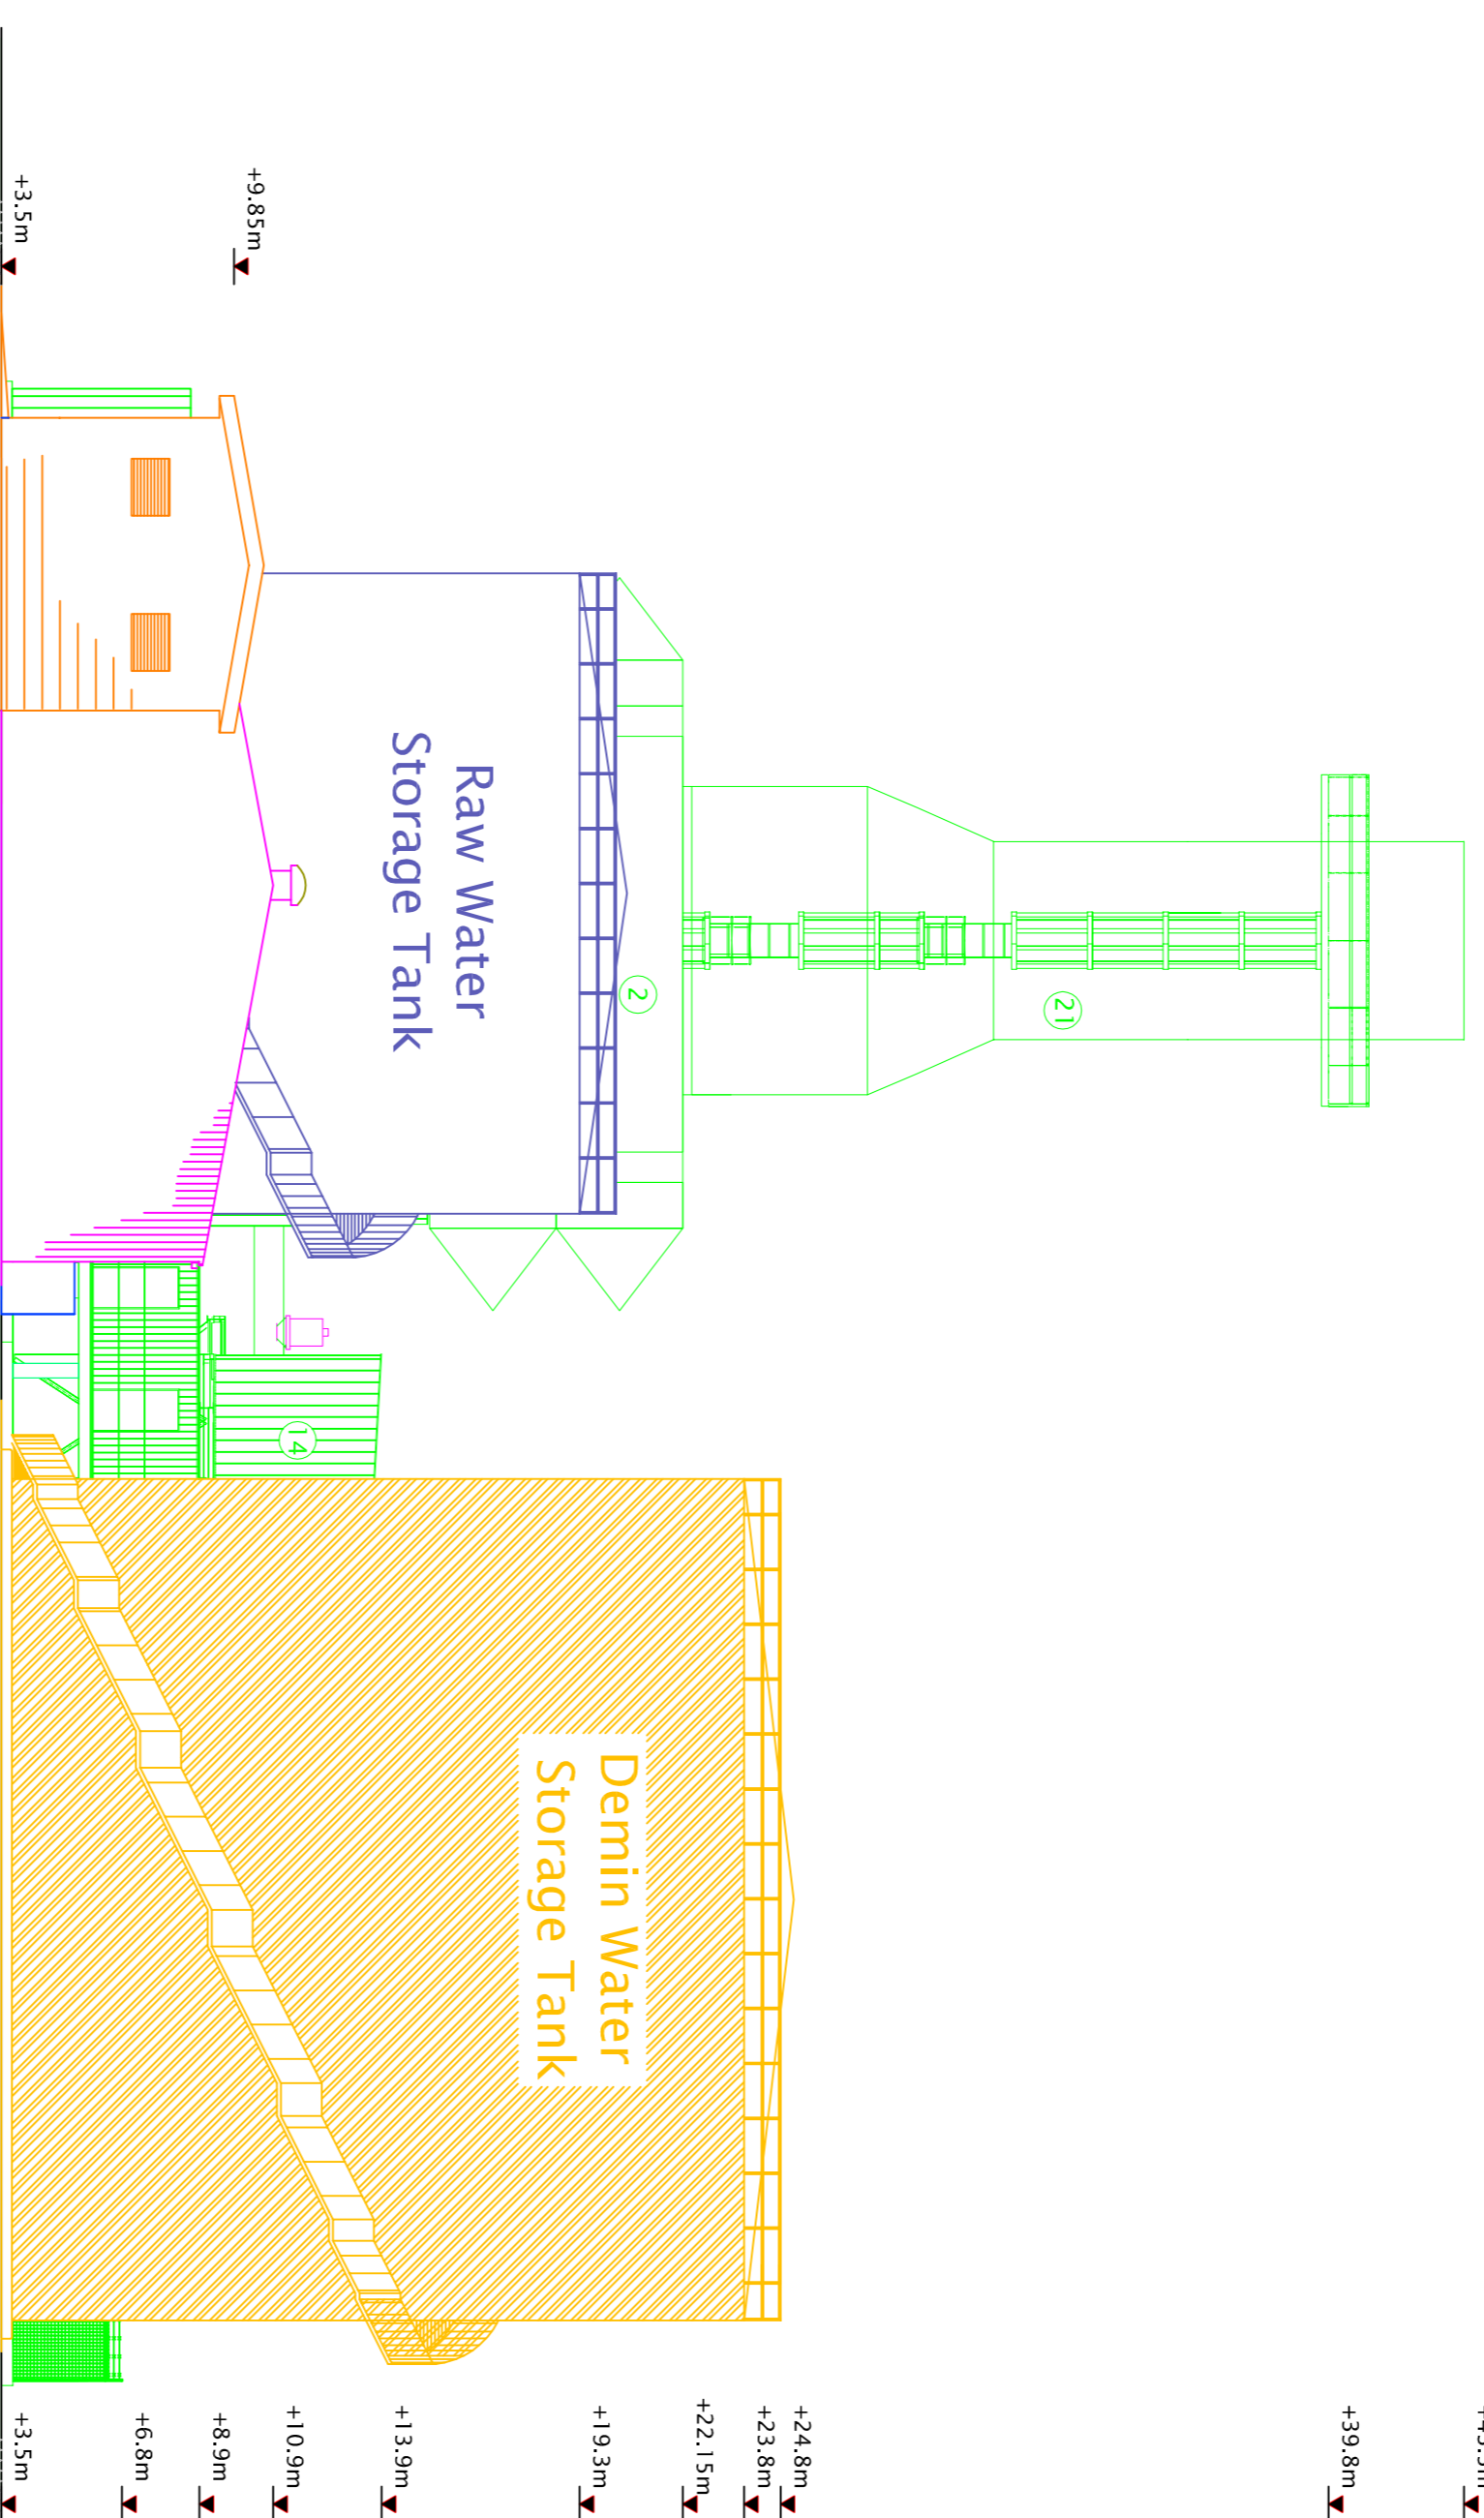


FOR CONTINUATION OF DRAWING  
REFER TO DRAWING 243190 C 019B


FOR CONTINUATION OF DRAWING  
REFER TO DRAWING 243190 C 019B

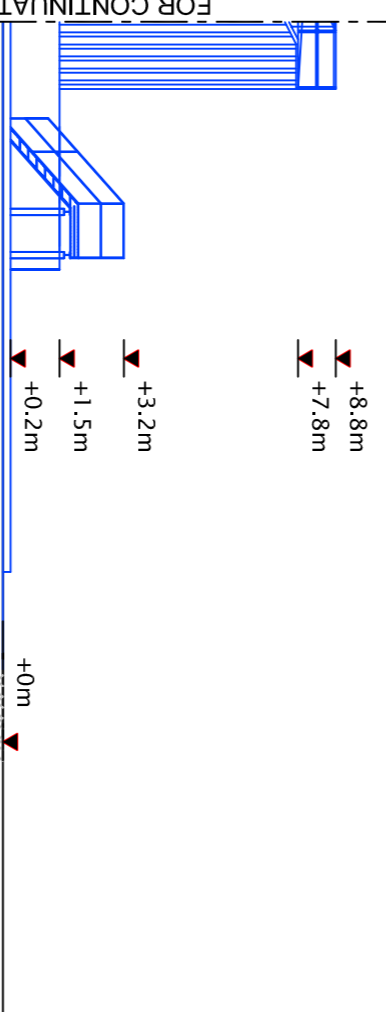

# KEY ELEVATION

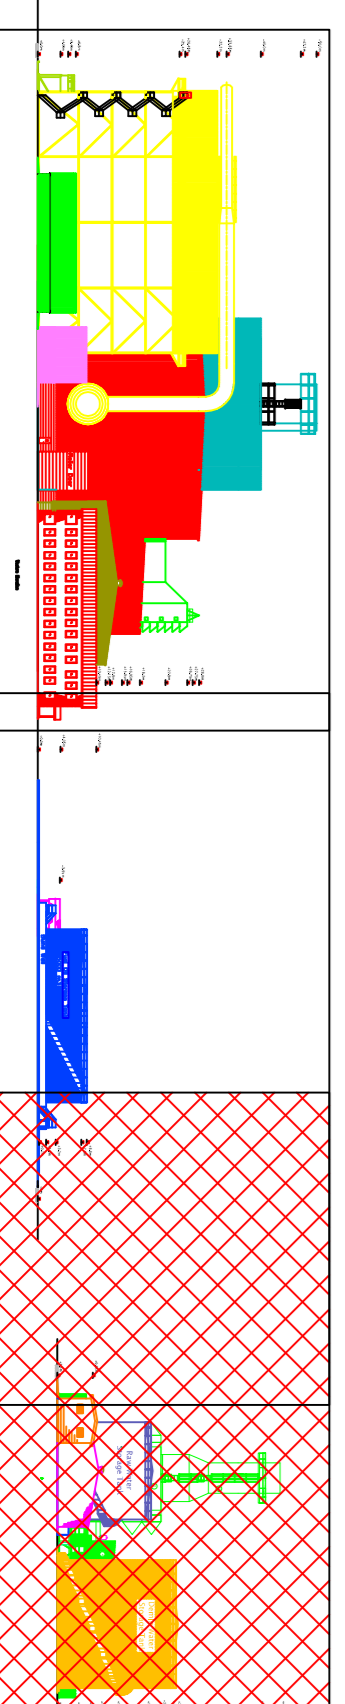

 Scale:



Rev	Date	Drawn	Description	CHK'd	App'd
R1	27/02/09	REN	Issue For Planning Application	DMR	DMR
R0	21/12/08	REN	Issue for Comments	DMR	DMR

**M Mott MacDonald**

Mott MacDonald Permit Ltd.  
South Block, Rockfield,  
Dundrum, Dublin 16,  
Ireland  
Tel: +353 (0) 291 6700  
Fax: +353 (0) 291 6701  
Web: www.mottmacdonald.ie  
Email: engineers@mottmacpetit.ie

**BORD NA MÓNA**

**BORD NA MONA ENERGY LIMITED**  
DERRYGREENAGH, ROCHFORTBRIDGE,  
MULLINGAR, CO. WESTMEATH

The Bord na Mona Energy  
Proposed Power Plant at Derrygreenagh  
Proposed Site Elevations - Western Elevation  
Sheet 3 of 3

Designed	Eng.Chk.	Donal McRendall
Drawn	R Evers-Norton	
Dwg.Chk.	Donal McRendall	O McRendall
Scale	Project 243190	Status
1:200	CAD file 243190 C 019.dwg	PRE

Drawing No 243190 C 019C Rev R1